

SCALE 1"=1,000'

PREPARED FOR

WESTWOOD, MA 02090

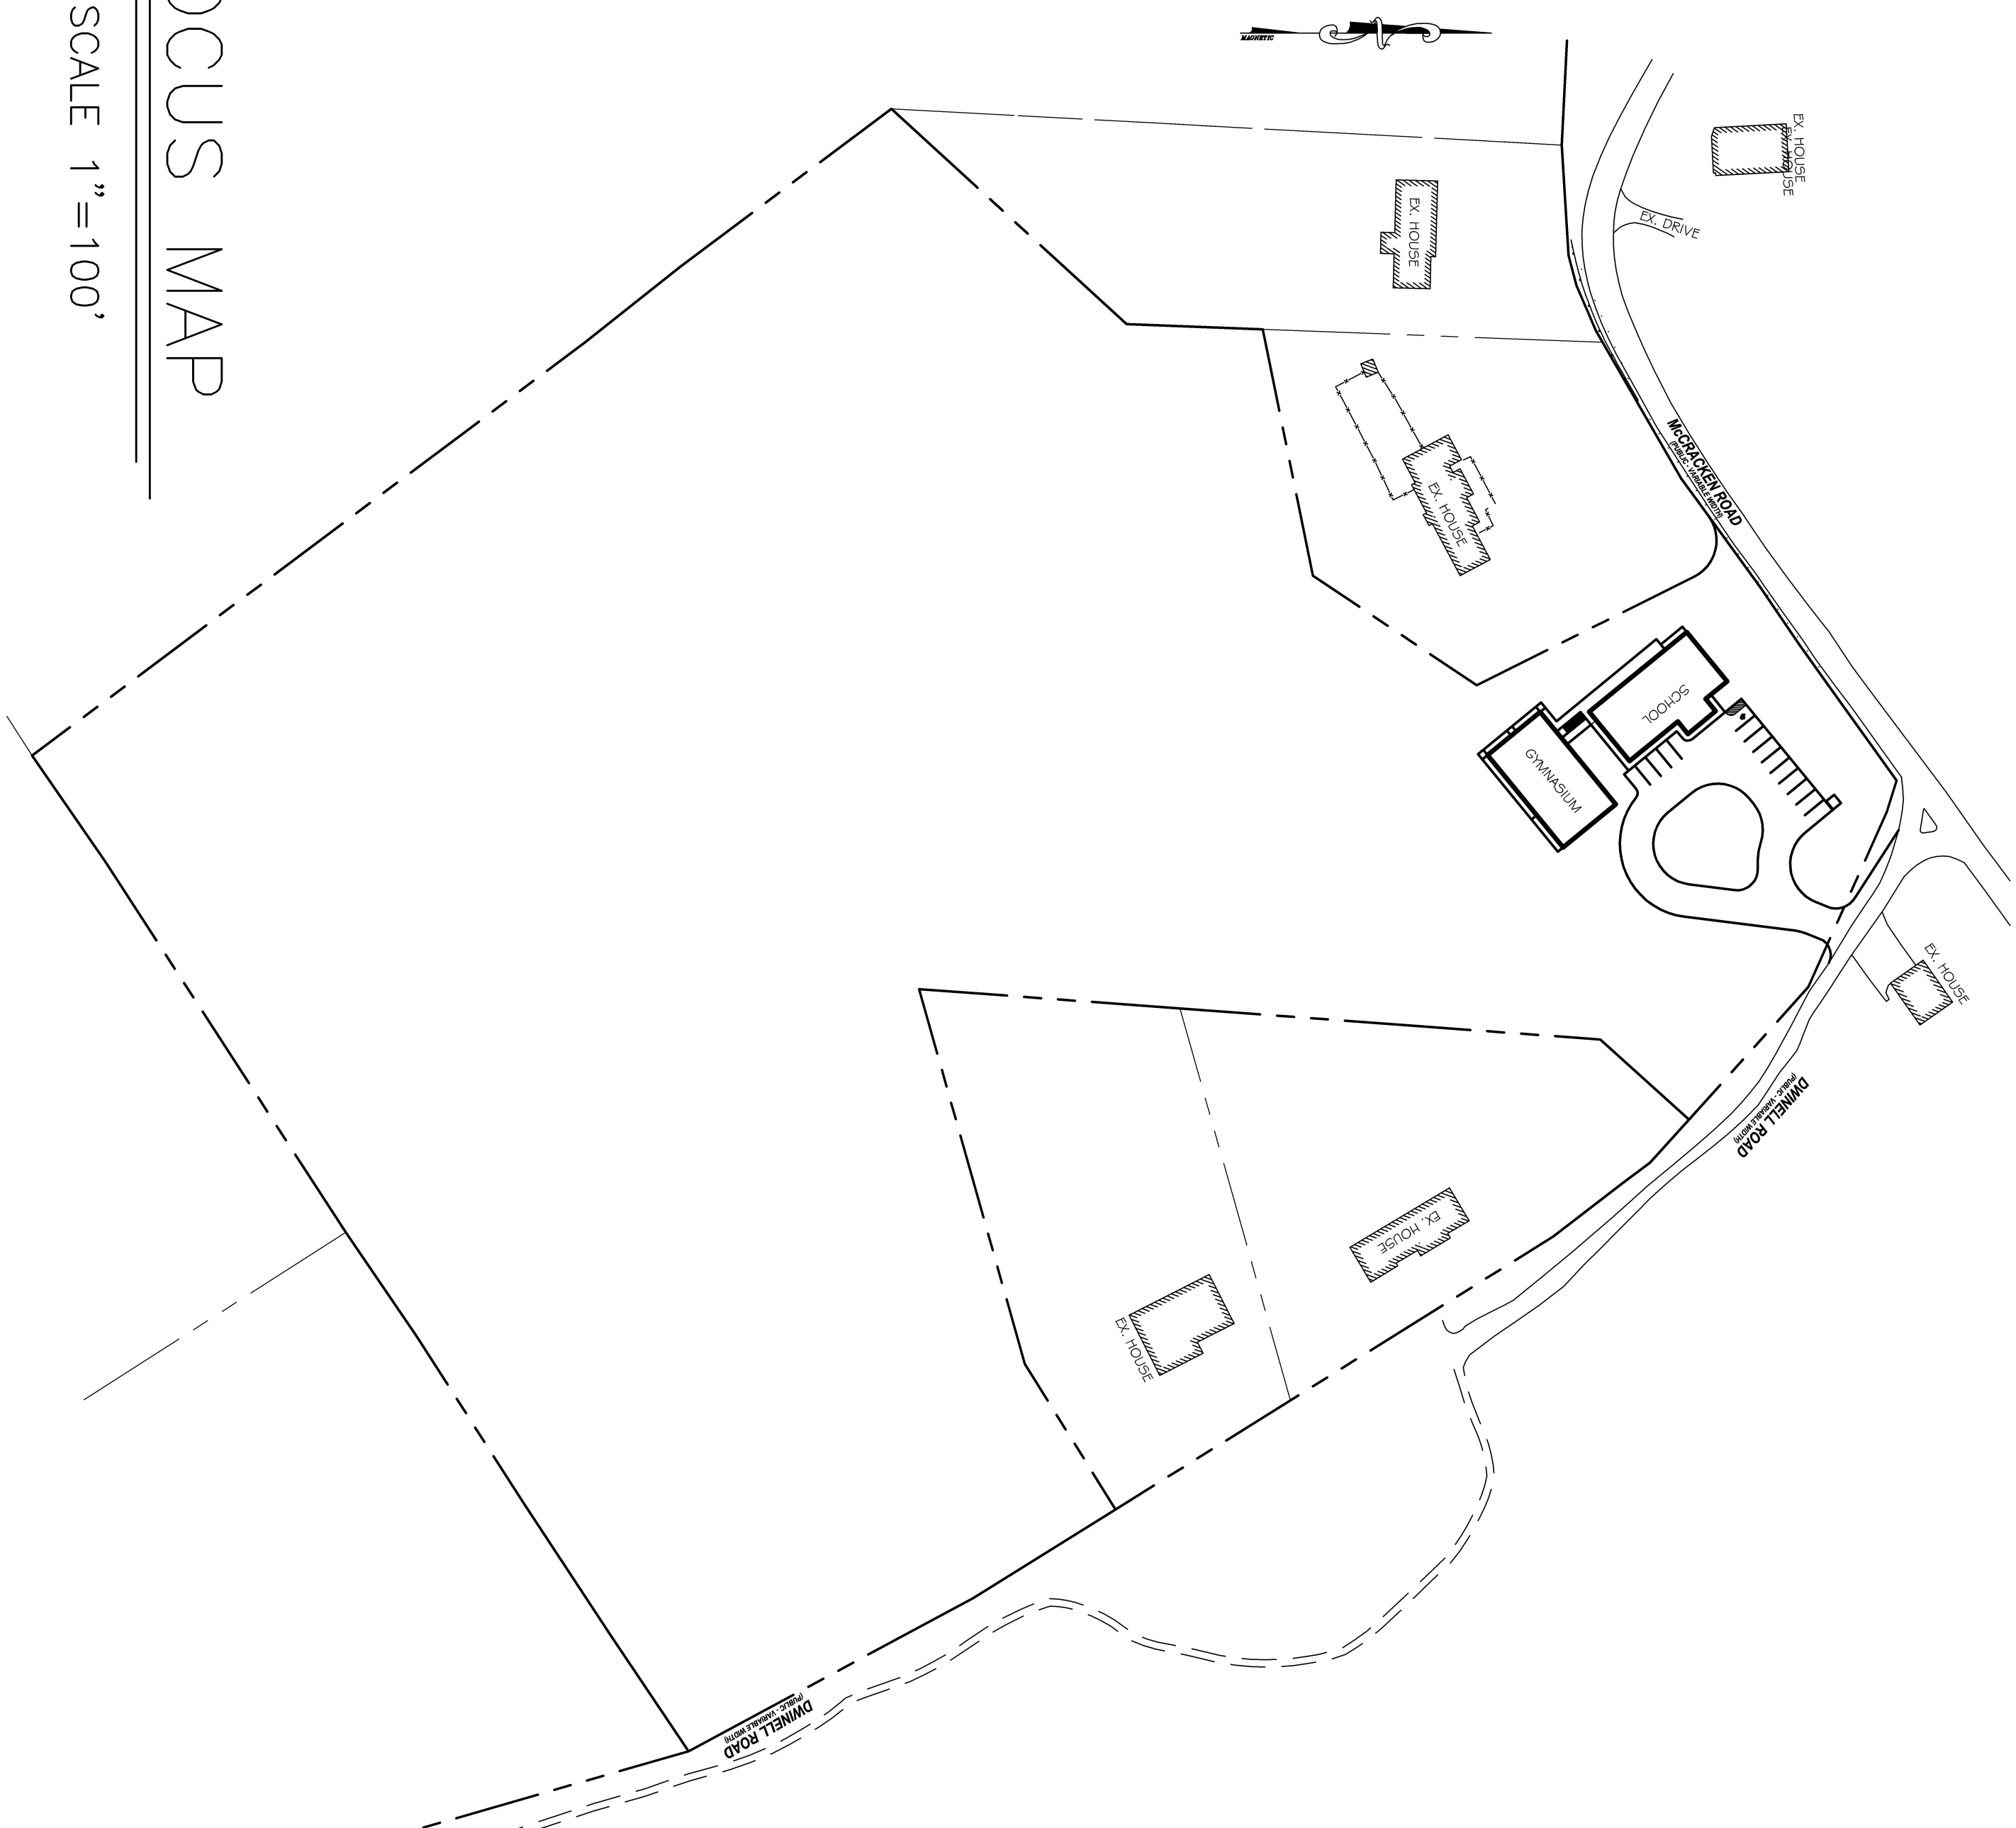


TABLE OF CONTENTS

SHEET 1	COVER
SHEET 2	OVERALL SITE DEVELOPMENT PLAN
SHEET 3	OVERALL SITE DEVELOPMENT PLAN
SHEET 4	EXISTING CONDITIONS PLAN
SHEET 5	SITE DEVELOPMENT PLAN
SHEET 6	LANDSCAPE PLAN
SHEET 7	EROSION CONTROL PLAN & DETAILS
SHEET 8	SITE DETAILS
SHEET 9	SITE DETAILS
SHEET 10	SITE DETAILS
SHEET 11	LIGHTING PLAN & DETAILS

SCALE 1"=100'

SITE PLAN APPROVAL
MILLBURY PLANNING BOARD

DATE: _____

Job #: 19058.00	Drawing #: 1	<div><div>RES</div><div>CIVIL ENGINEERING CONSULTANTS</div><div>63 NORWICH AVE. - STE 202 COLCHESTER, CT (860) 465-7419</div><div>Reynolds Engineering Services, LLC</div></div>	COVER		Drawing date: 2/1/20		Drawing Scale: AS NOTED		Designed By: MAR			
			PROJECT TITLE:	NEW ENGLAND CAMPUS		Rev.	Date	Revision		By	Drawn By: MAR	
				59 Dwinell Road		1	3/12/20	STAFF COMMENTS		MAR		
					MILLBURY, MA		2	6/11/20		STAFF COMMENTS	MAR	Checked By:
												CAD File: 19058.00
		PREPARED FOR: OneSchool Global New England										
		109 Juniper Ridge Road		WESTWOOD, MA 02090								