


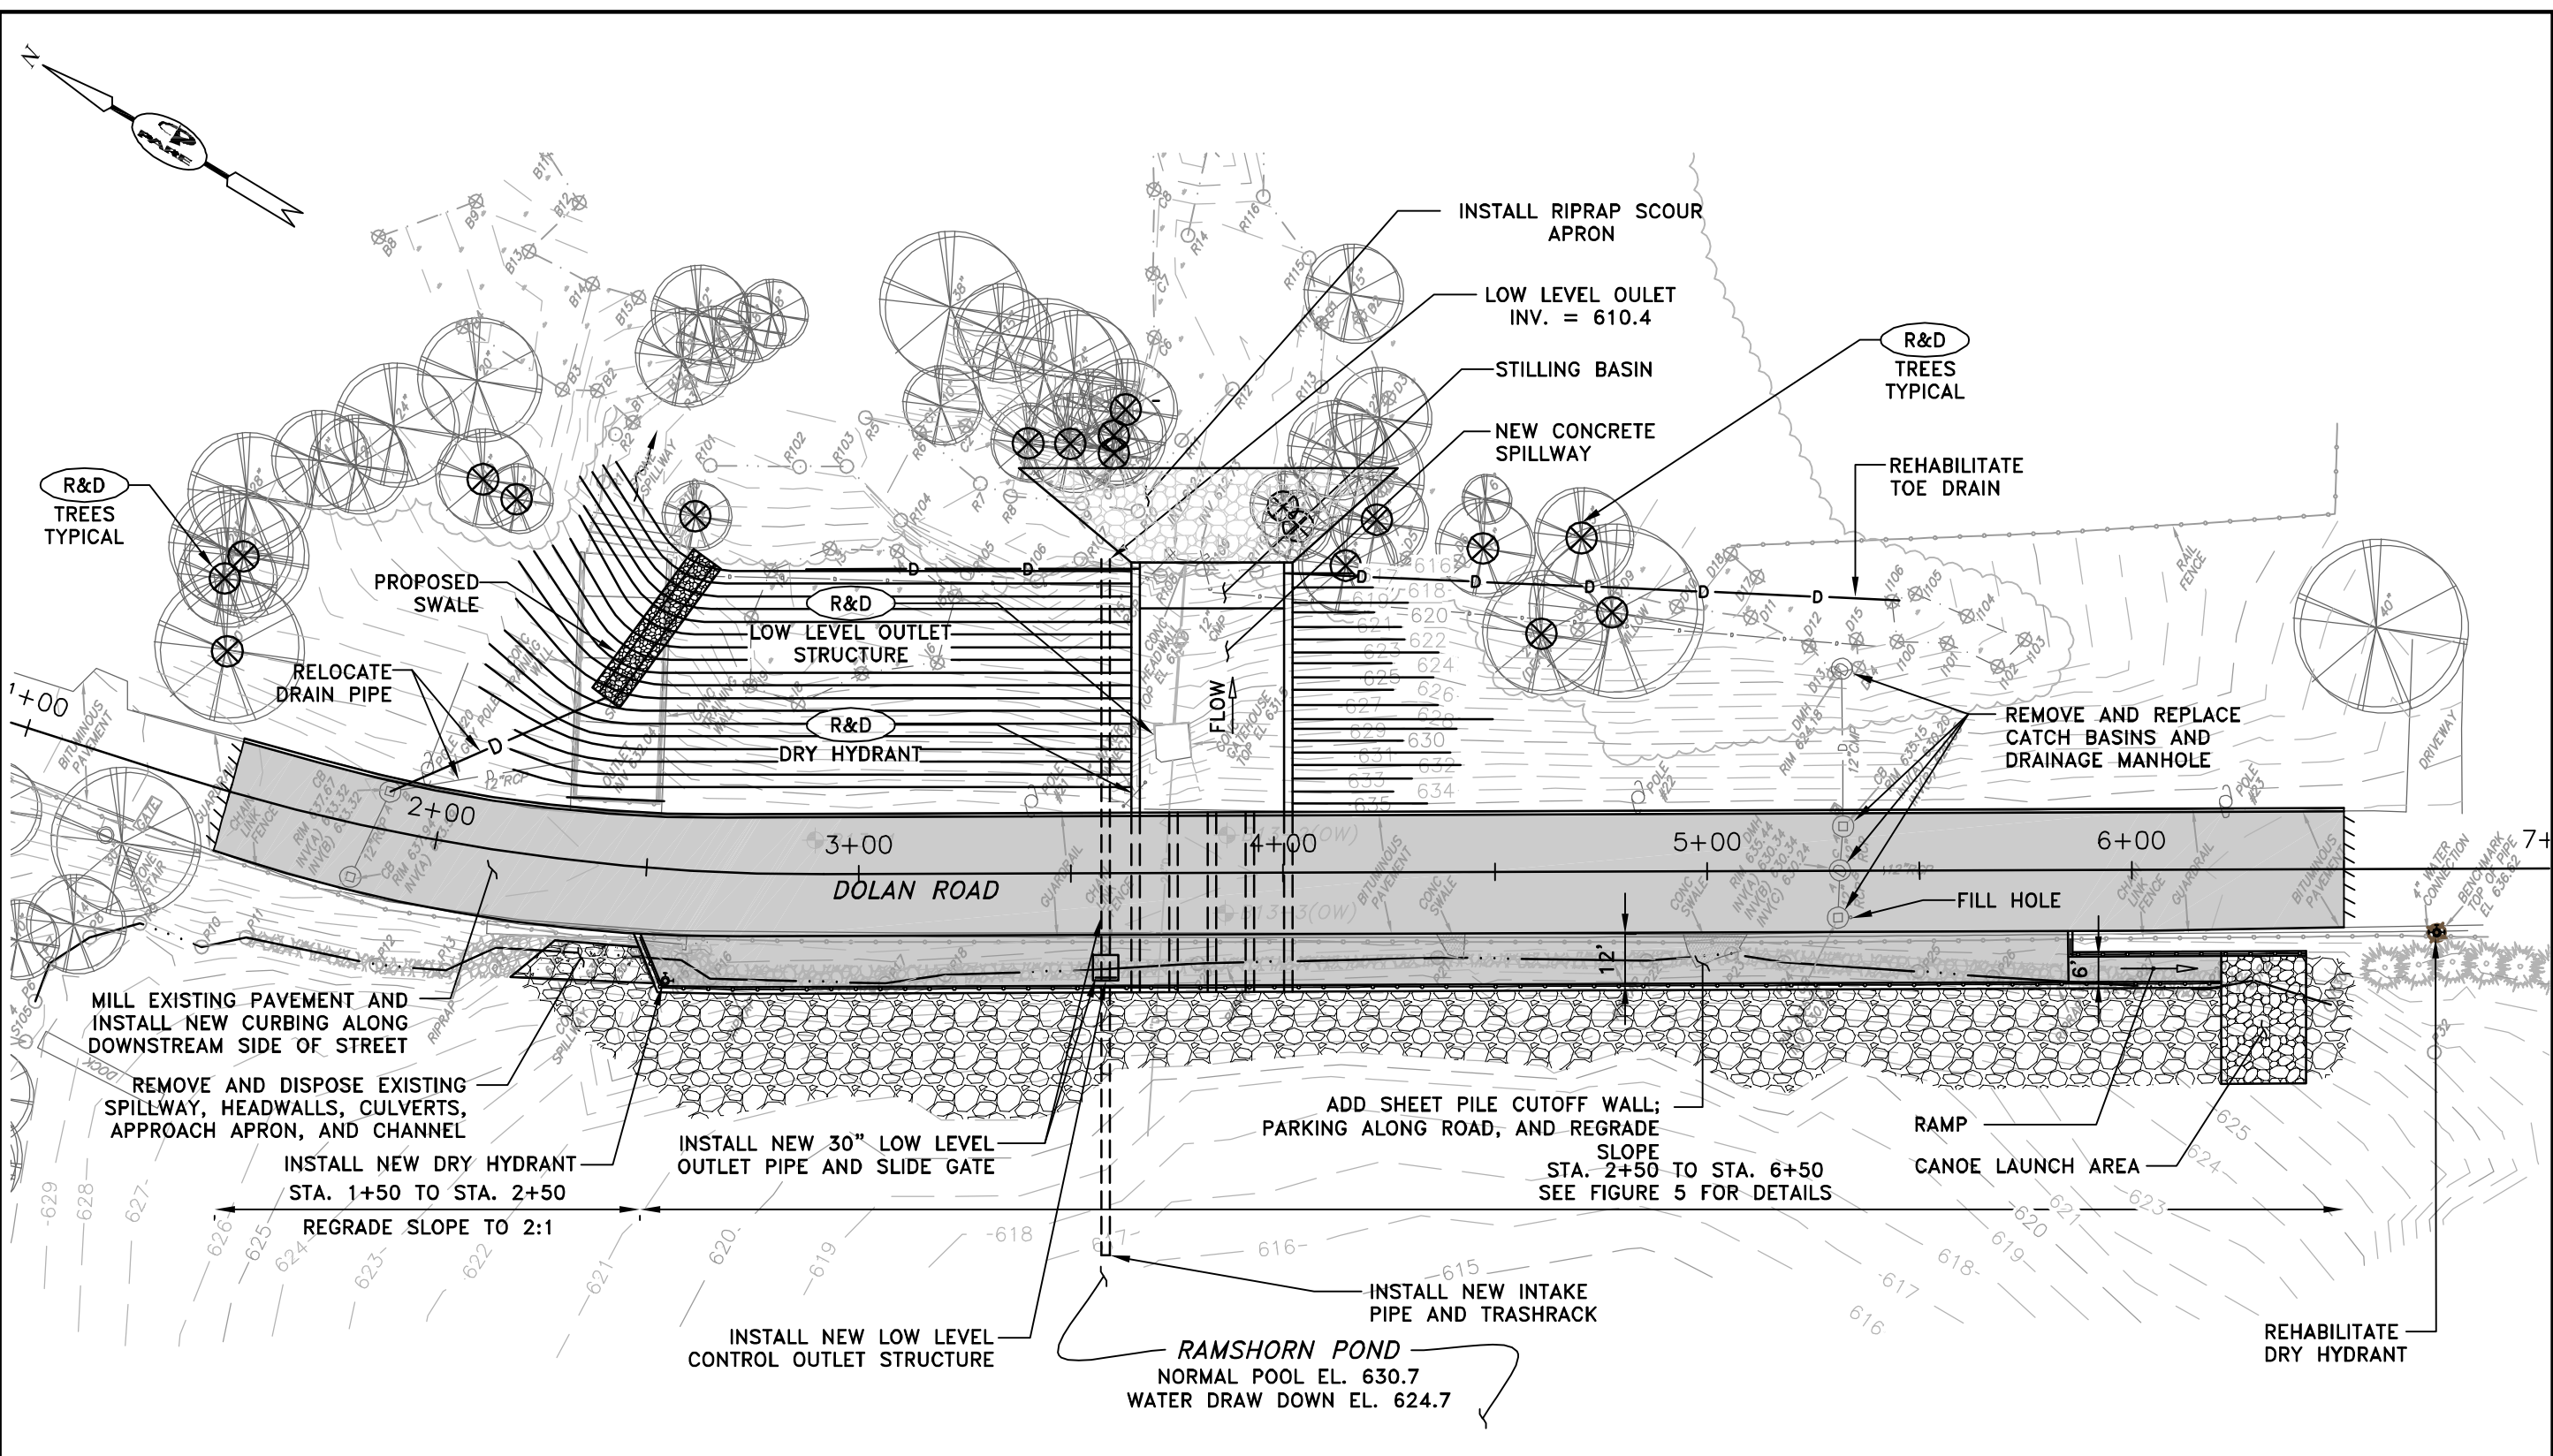

CONCEPTUAL REPAIRS
SCALE: 1"=40'

PARE CORPORATION
ENGINEERS - SCIENTISTS - PLANNERS
10 LINCOLN ROAD, SUITE 103
FOXBORO, MA 02835
508-543-1755

SCALE ADJUSTMENT GUIDE

0" 1"

BAR IS ONE INCH ON ORIGINAL DRAWING.

RAMSHORN POND DAM
MA00145 / 3-14-186-21
MILLBURY, MASSACHUSETTS
TOWN OF MILLBURY PUBLIC WORKS

REVISIONS:	

PROJECT NO.: 13072.00
DATE: OCTOBER 2013
SCALE: AS NOTED
DESIGNED BY: JMC
CHECKED BY: ARO
DRAWN BY: JHG
APPROVED BY: JMB

SCHEMATIC SITE PLAN

FIGURE NO.: 4